


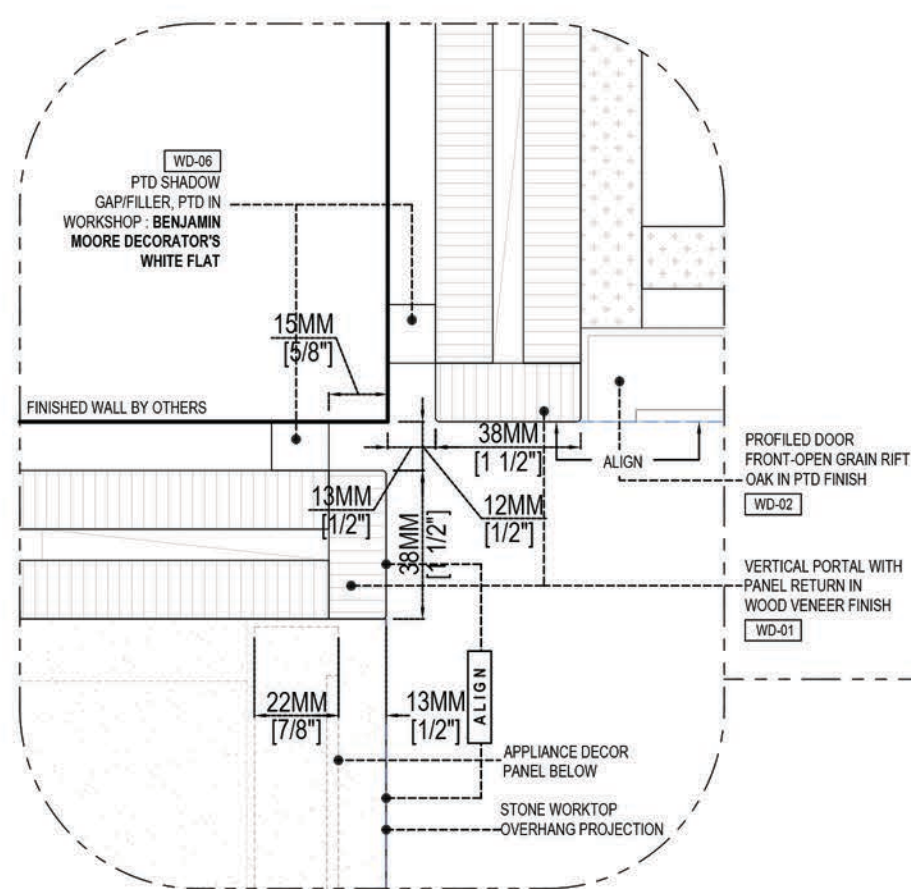


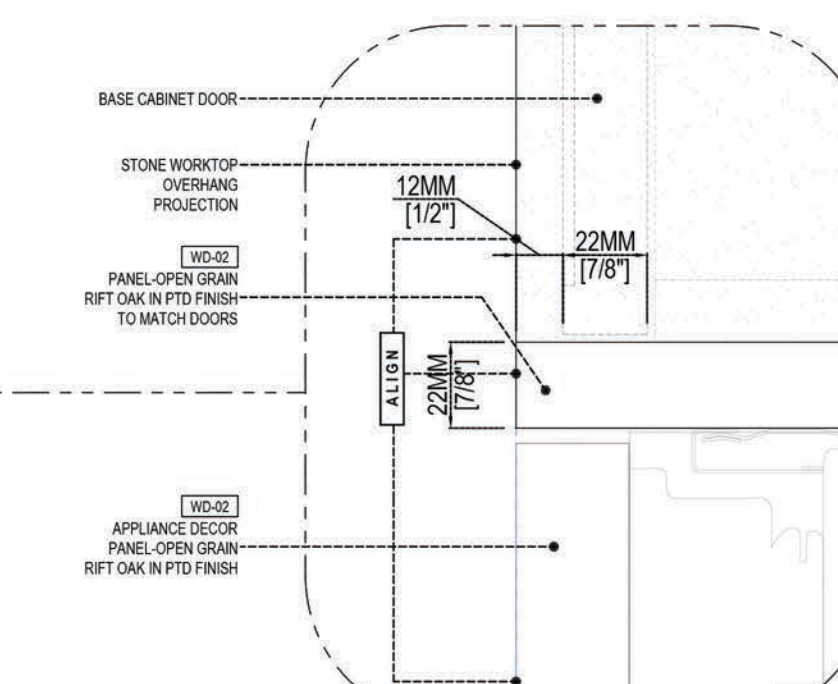

1
DETAIL-01
SCALE: 6" = 1'-0"

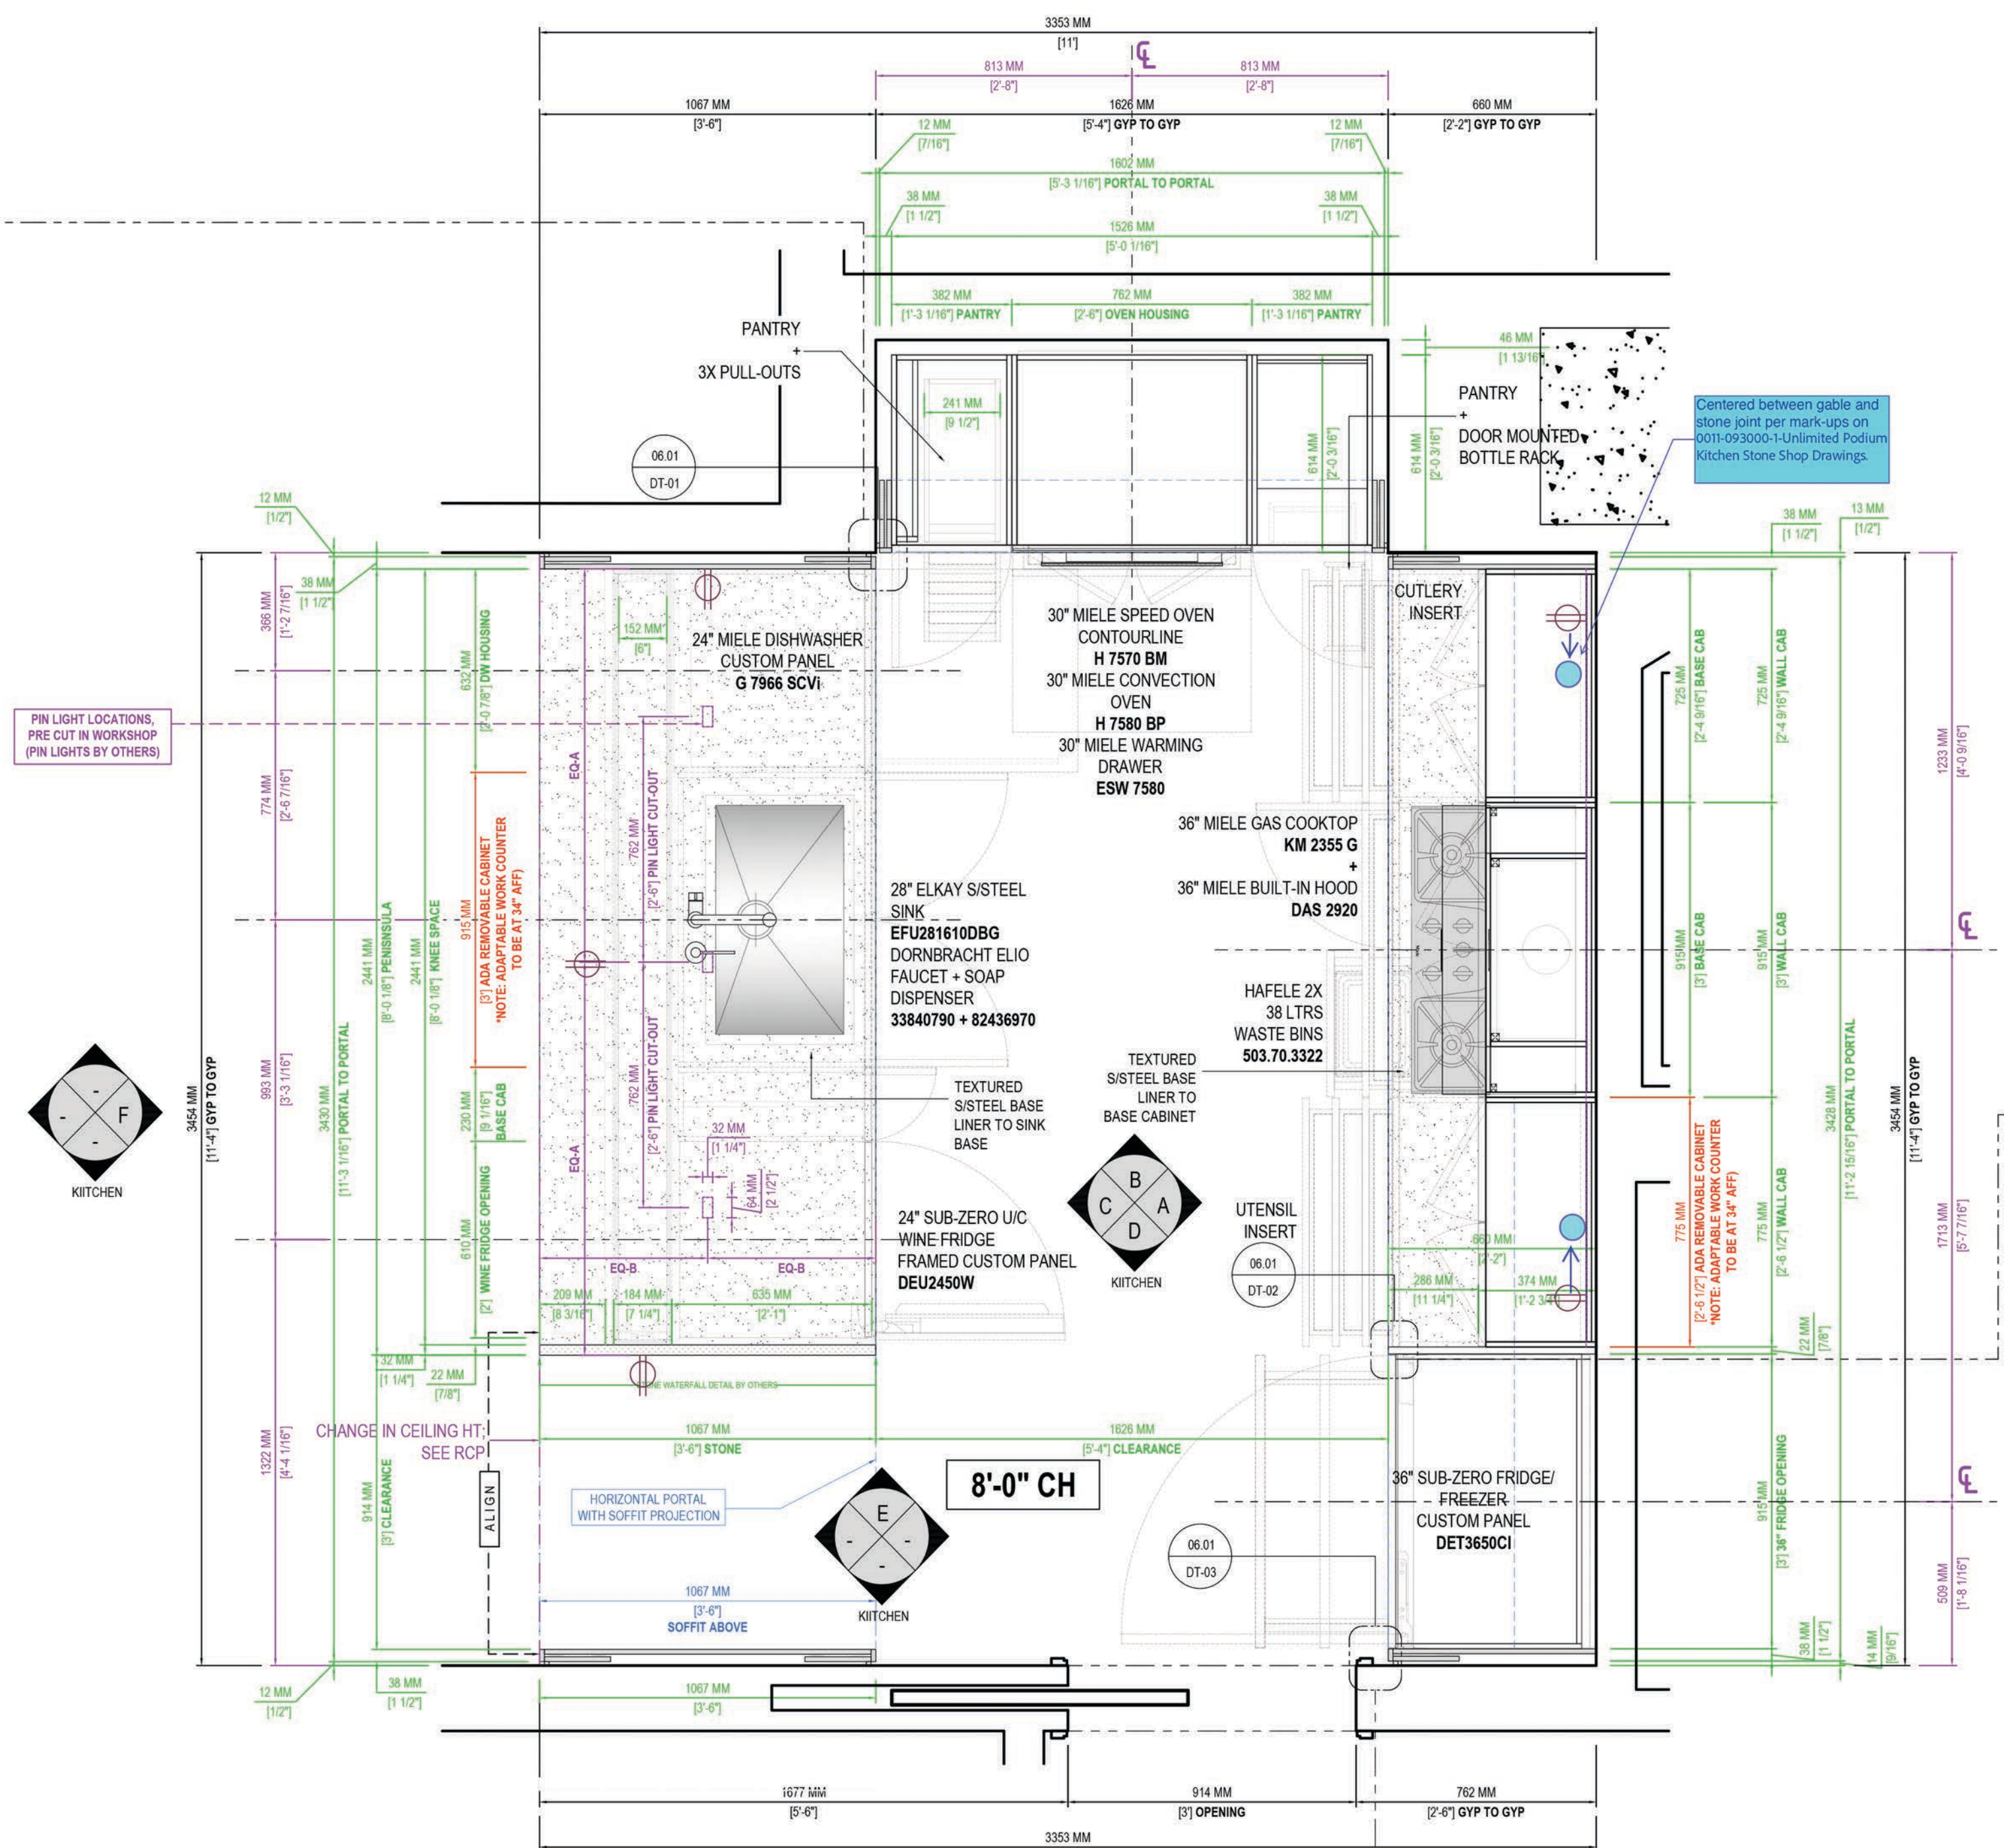

2
DETAIL-02
SCALE: 6" = 1'-0"


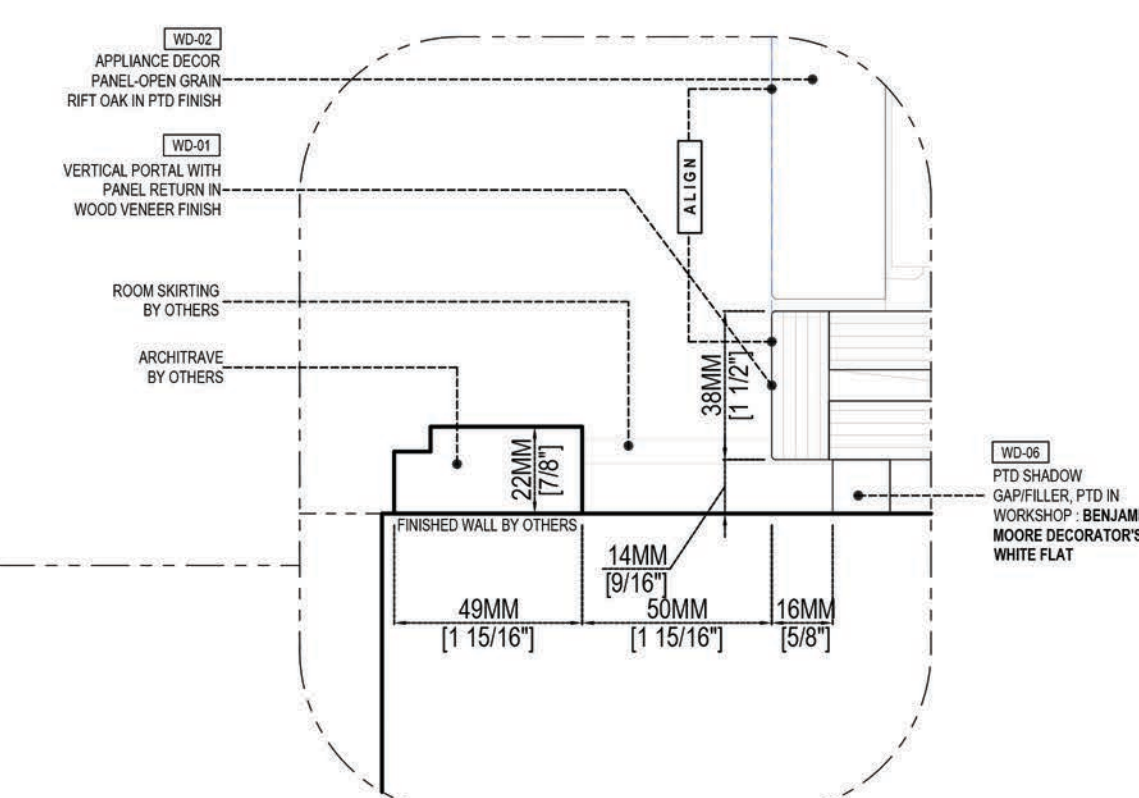


3
DETAIL-03
SCALE: 6" = 1'-0"

APARTMENT	FLOOR	QTY	FINISH SCHEME
F	02-14	13	LIGHT SCHEME

NOTE: DARK SCHEME AVAILABLE BY PURCHASER REQUEST ONLY

(1) ONE OF THESE LAYOUTS
NO CABINET HANDLES
NO APPLIANCES
NO PLUMBING FIXTURES

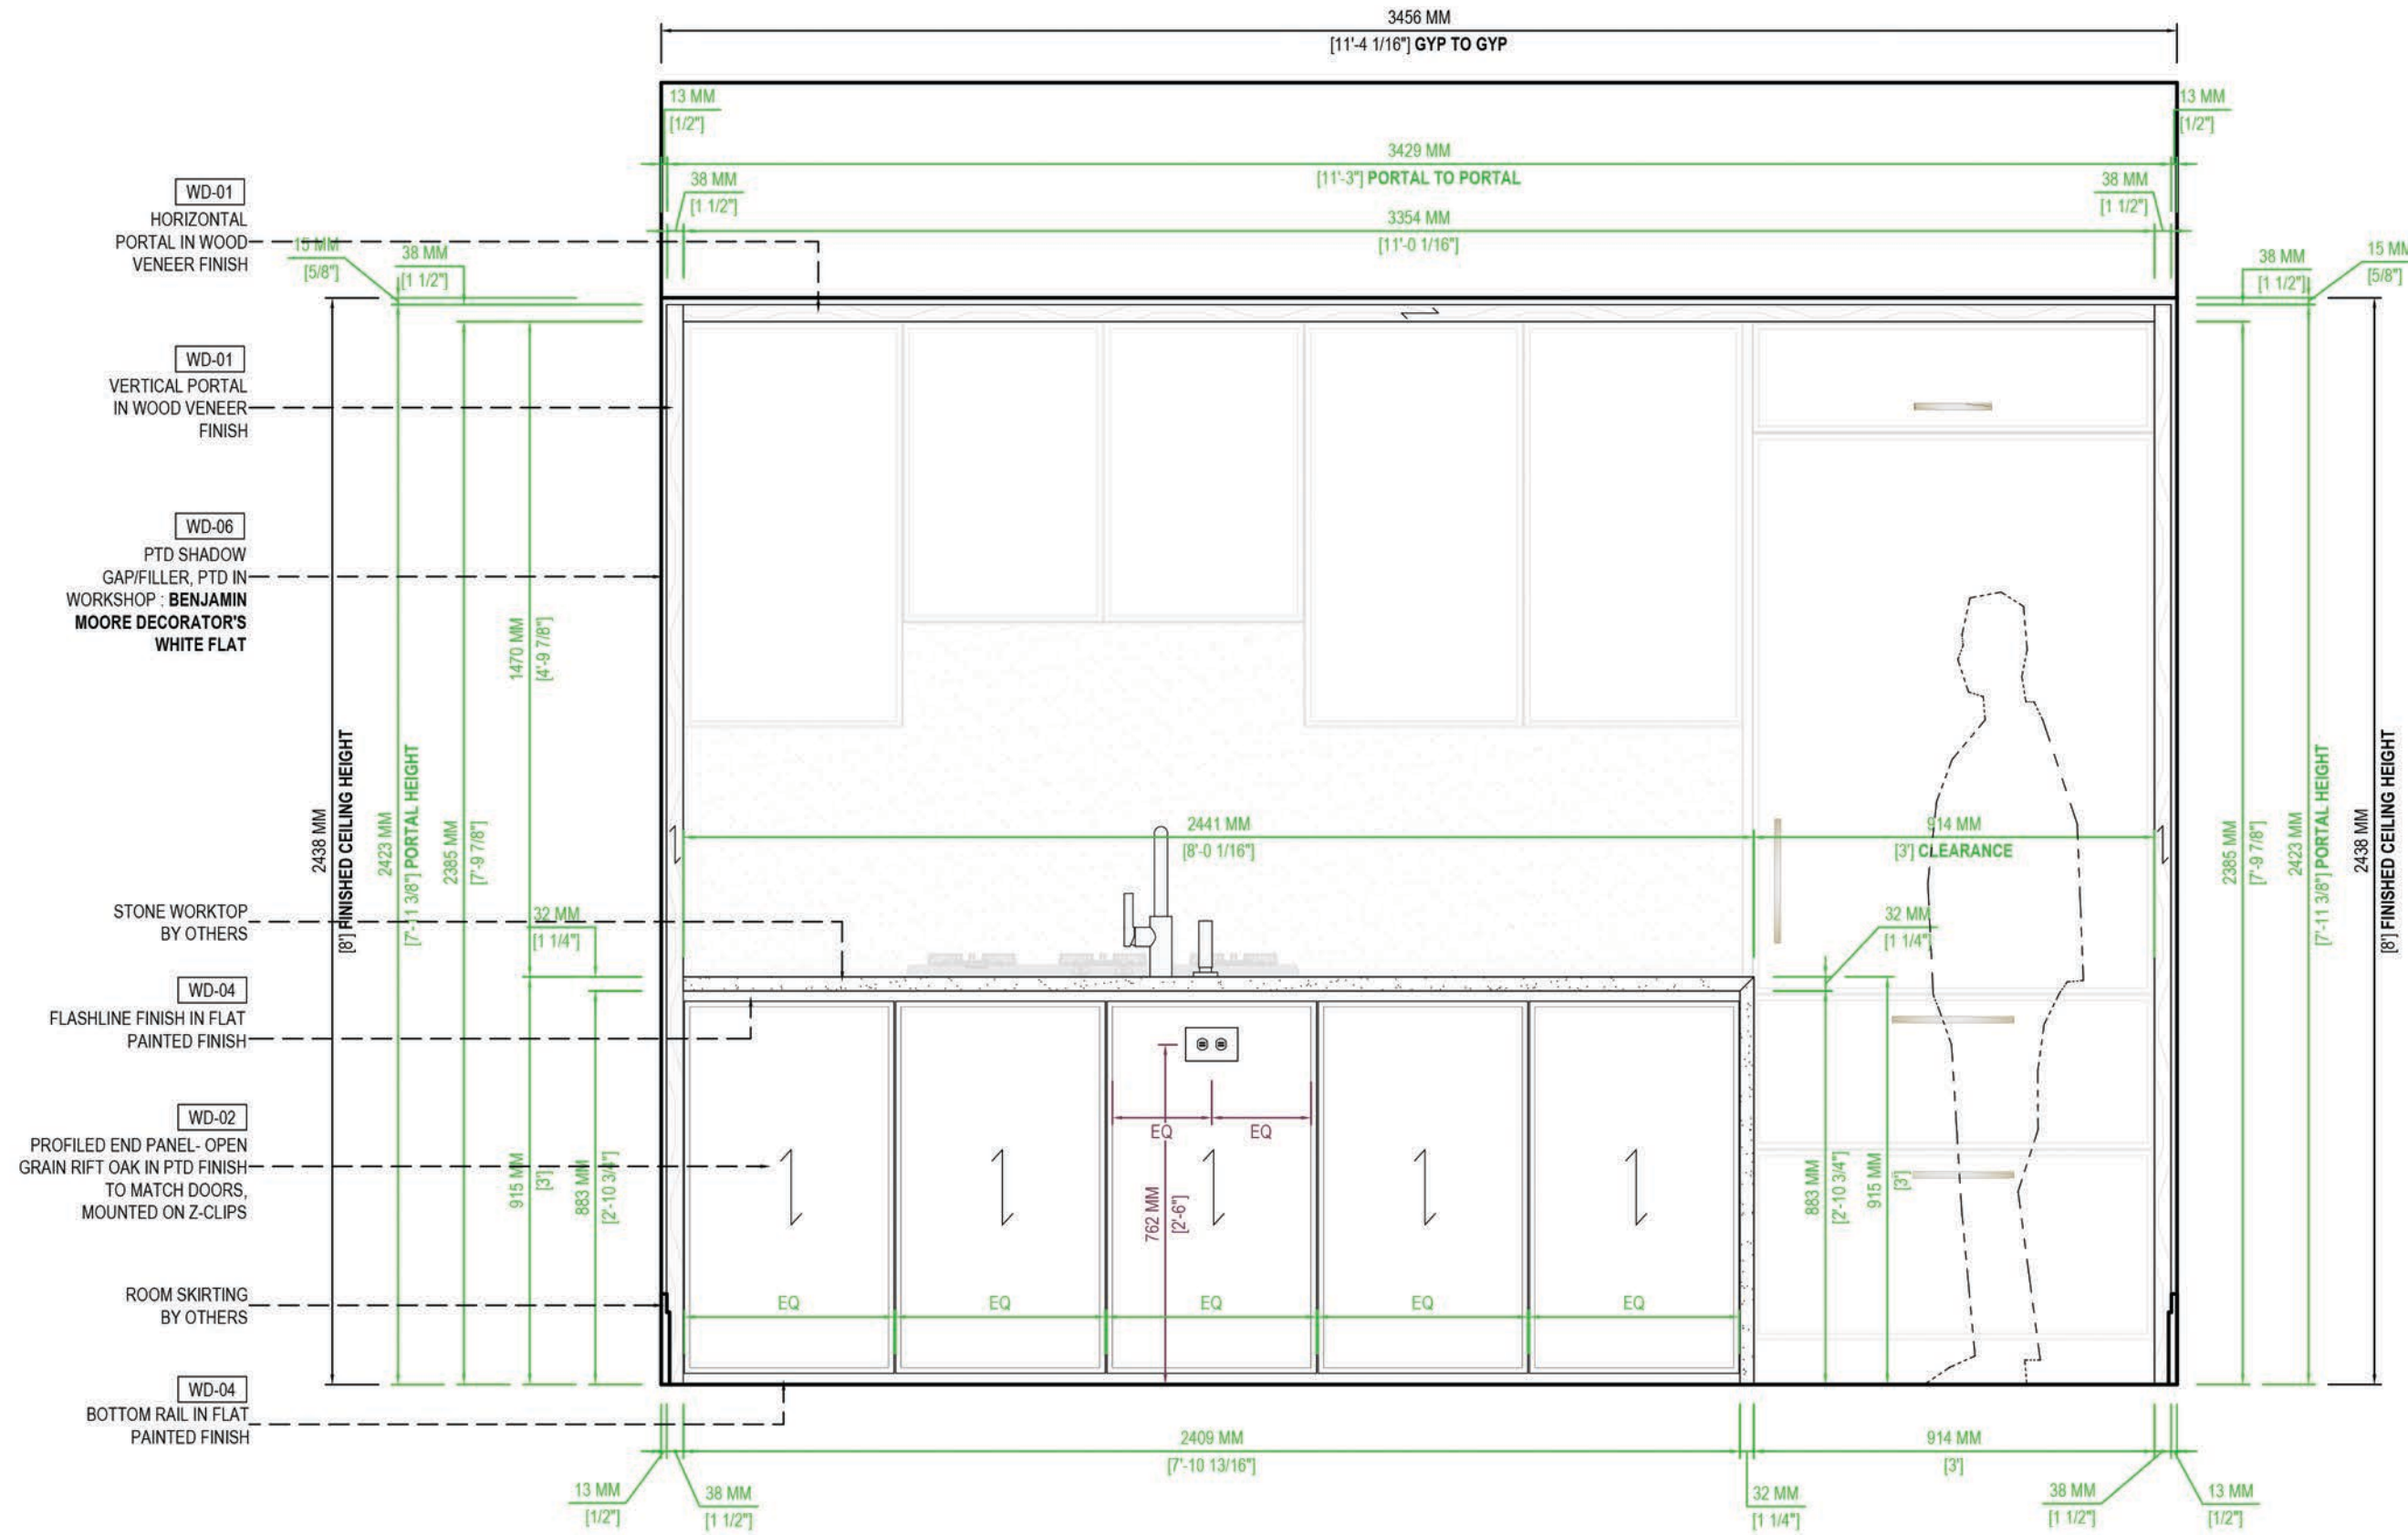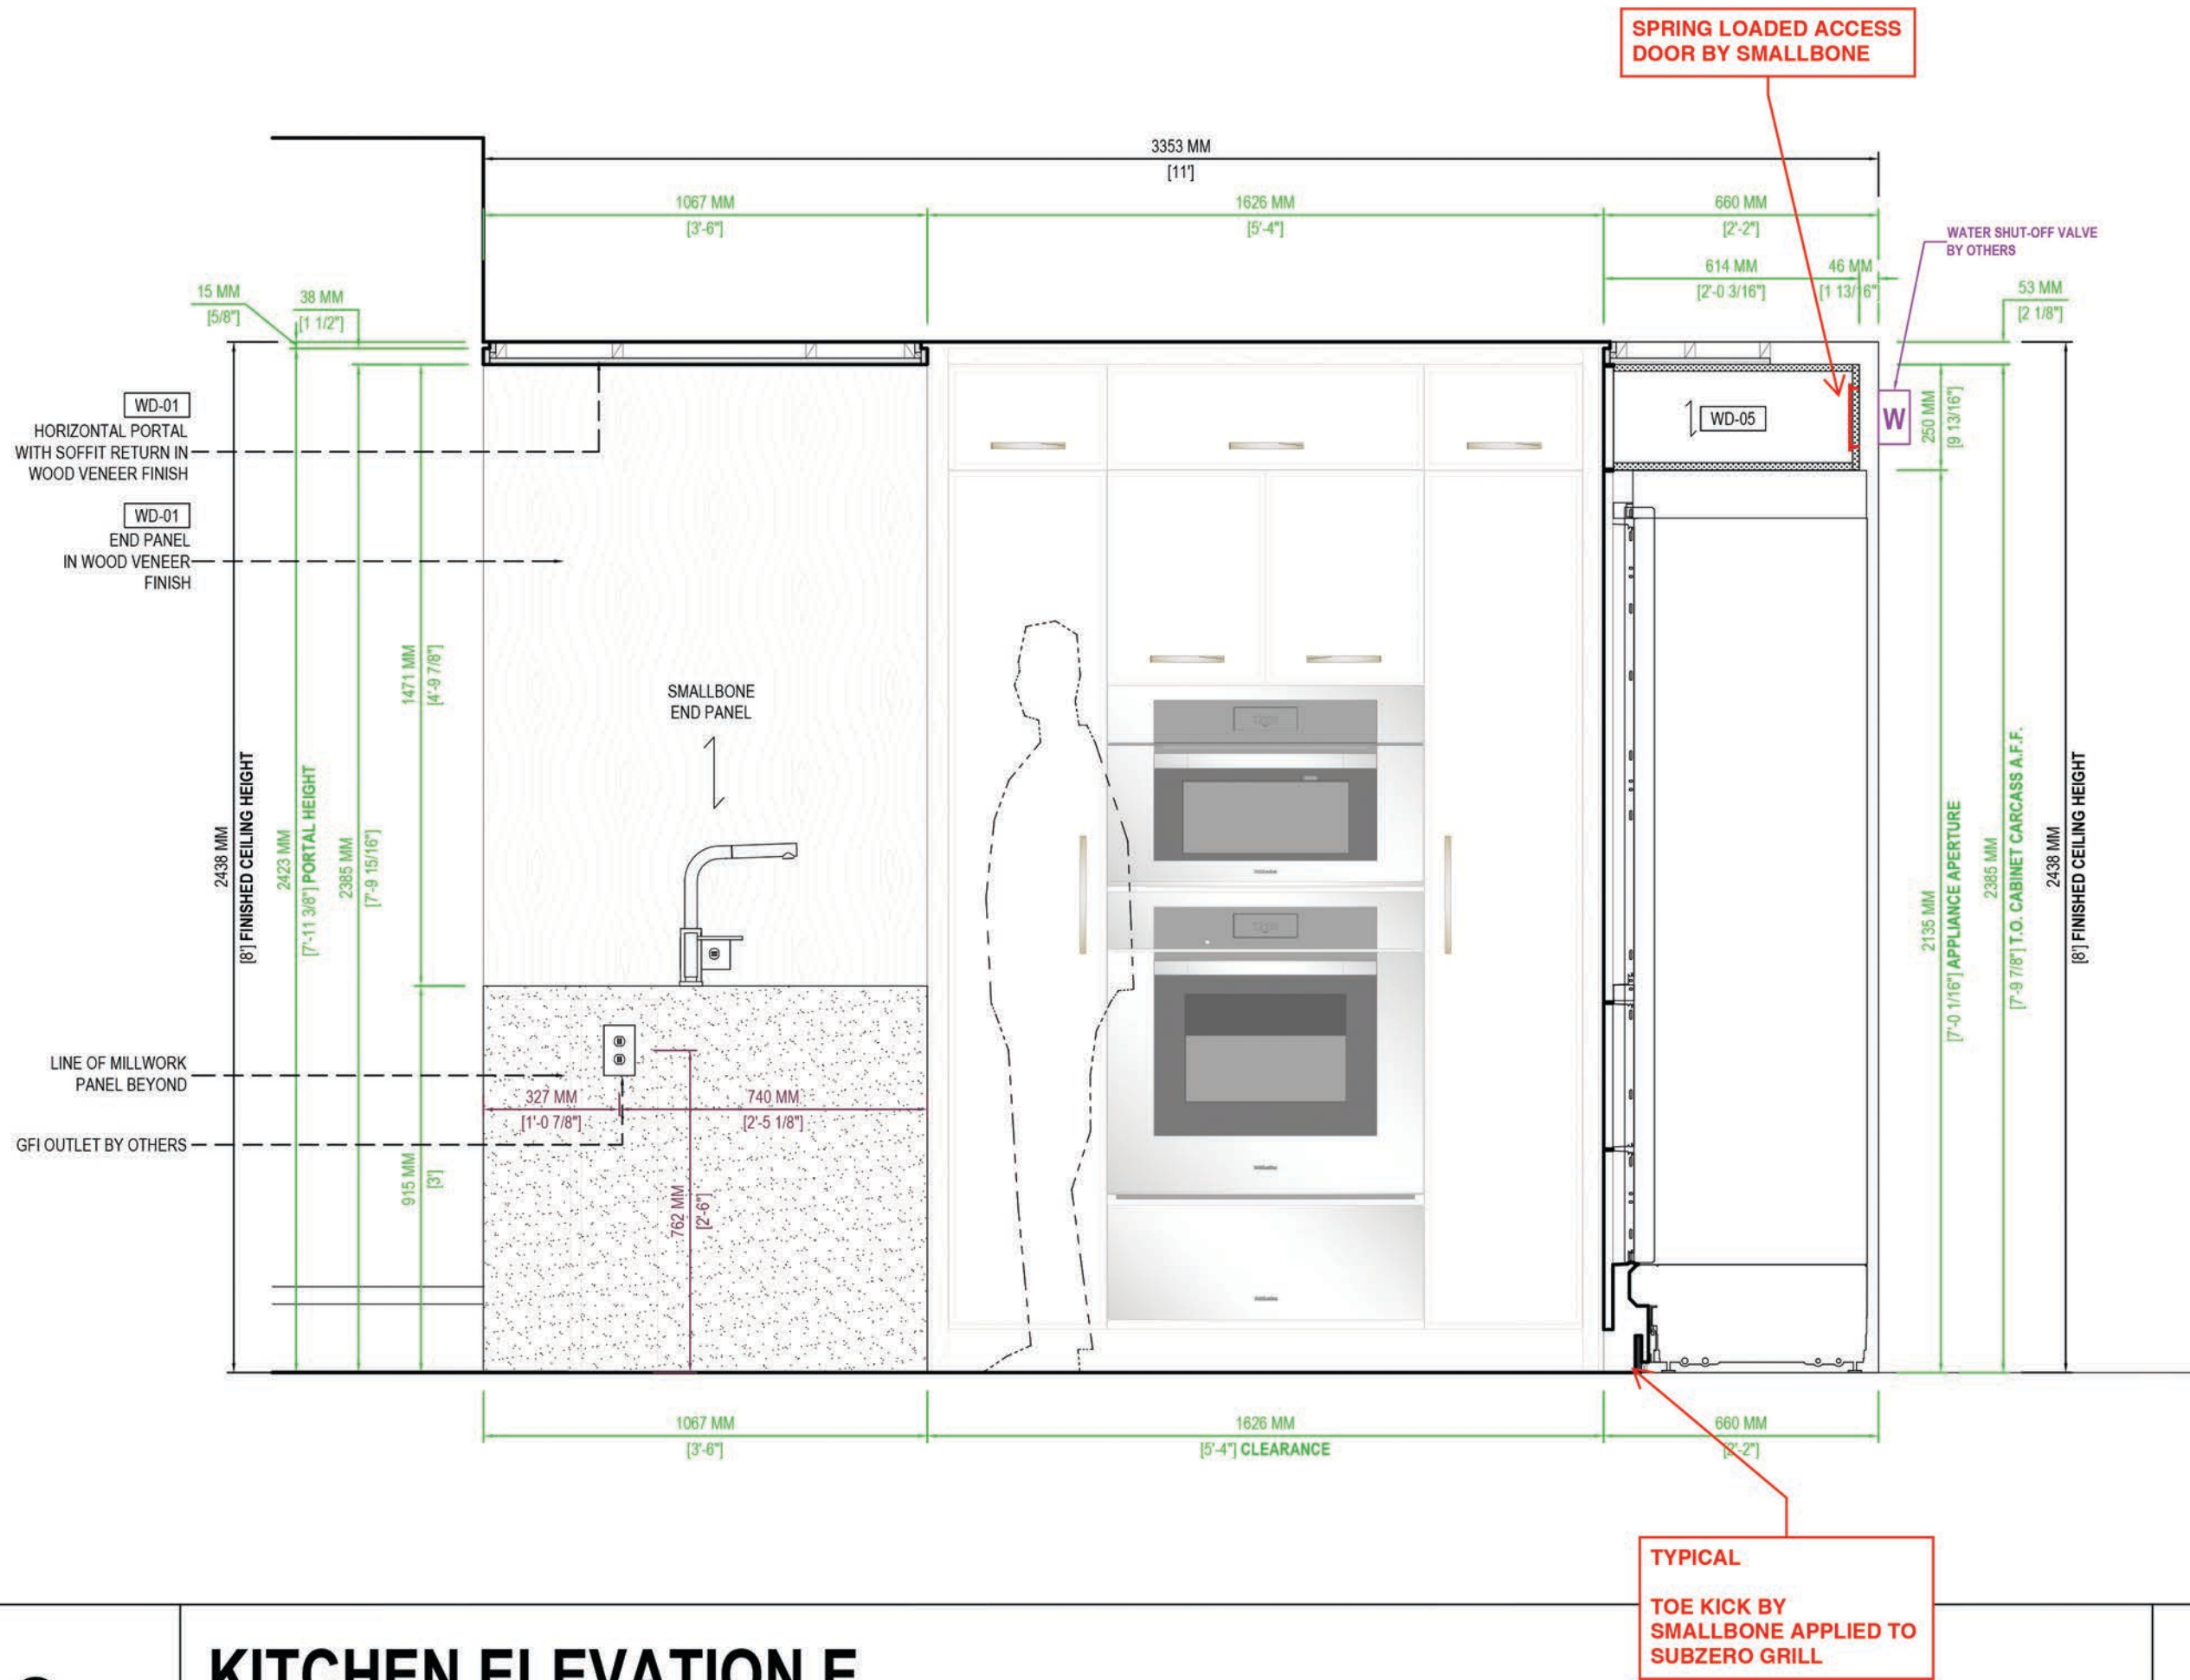

06

KITCHEN ELEVATION E
TYPE 4

SCALE

3/4"=1'-0"

07

KITCHEN ELEVATION F
TYPE 4

SCALE

3/4"=1'-0"