




2 **DETAIL-02**
SCALE: 6" = 1'-0"

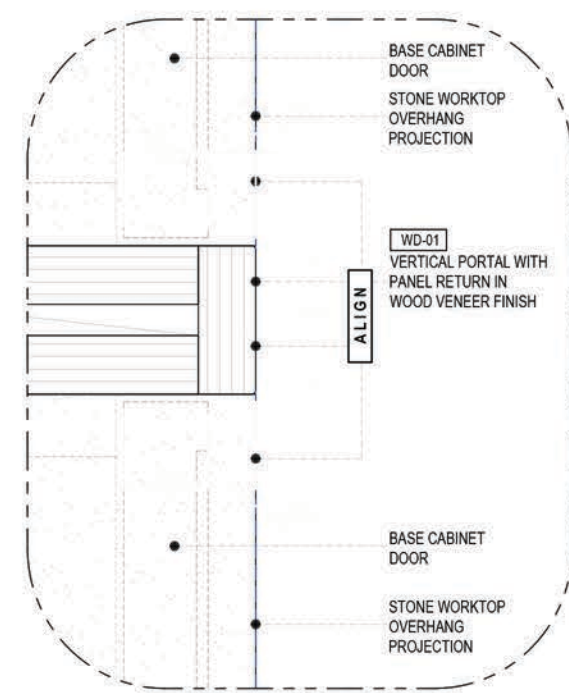

3 **DETAIL-03**
SCALE: 6" = 1'-0"

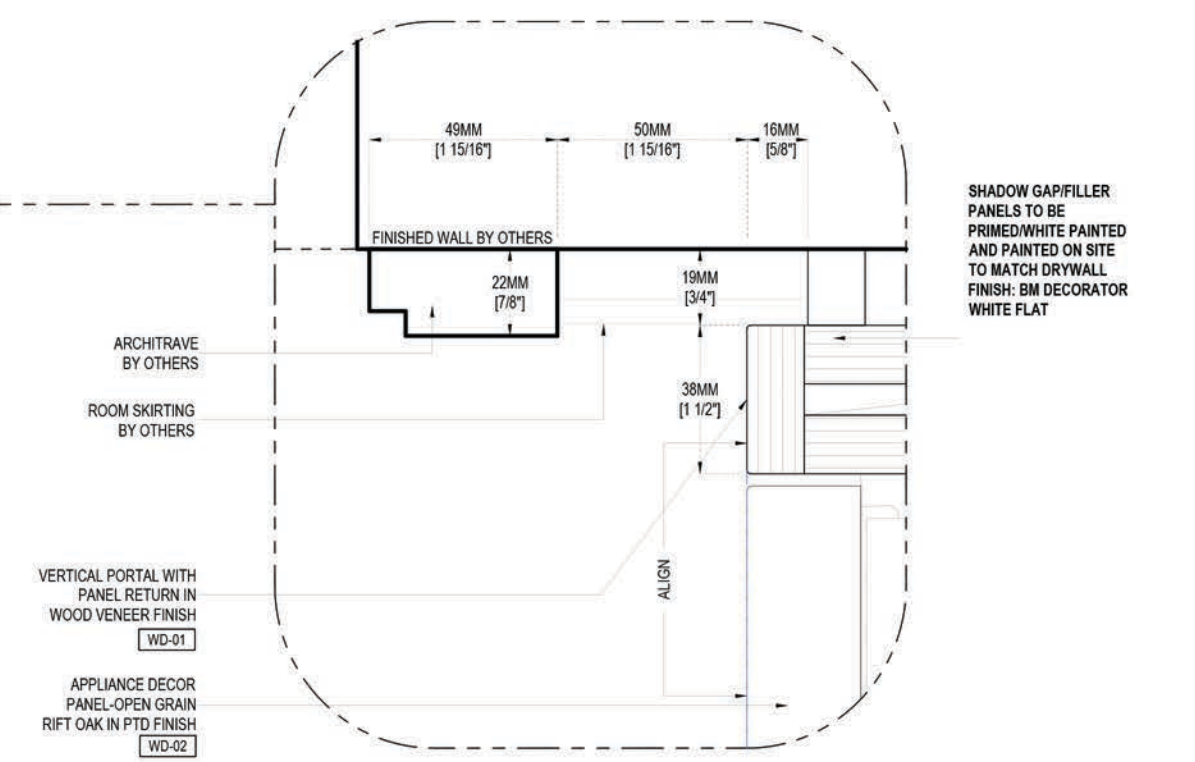


1 **DETAIL-01**
SCALE: 6" = 1'-0"

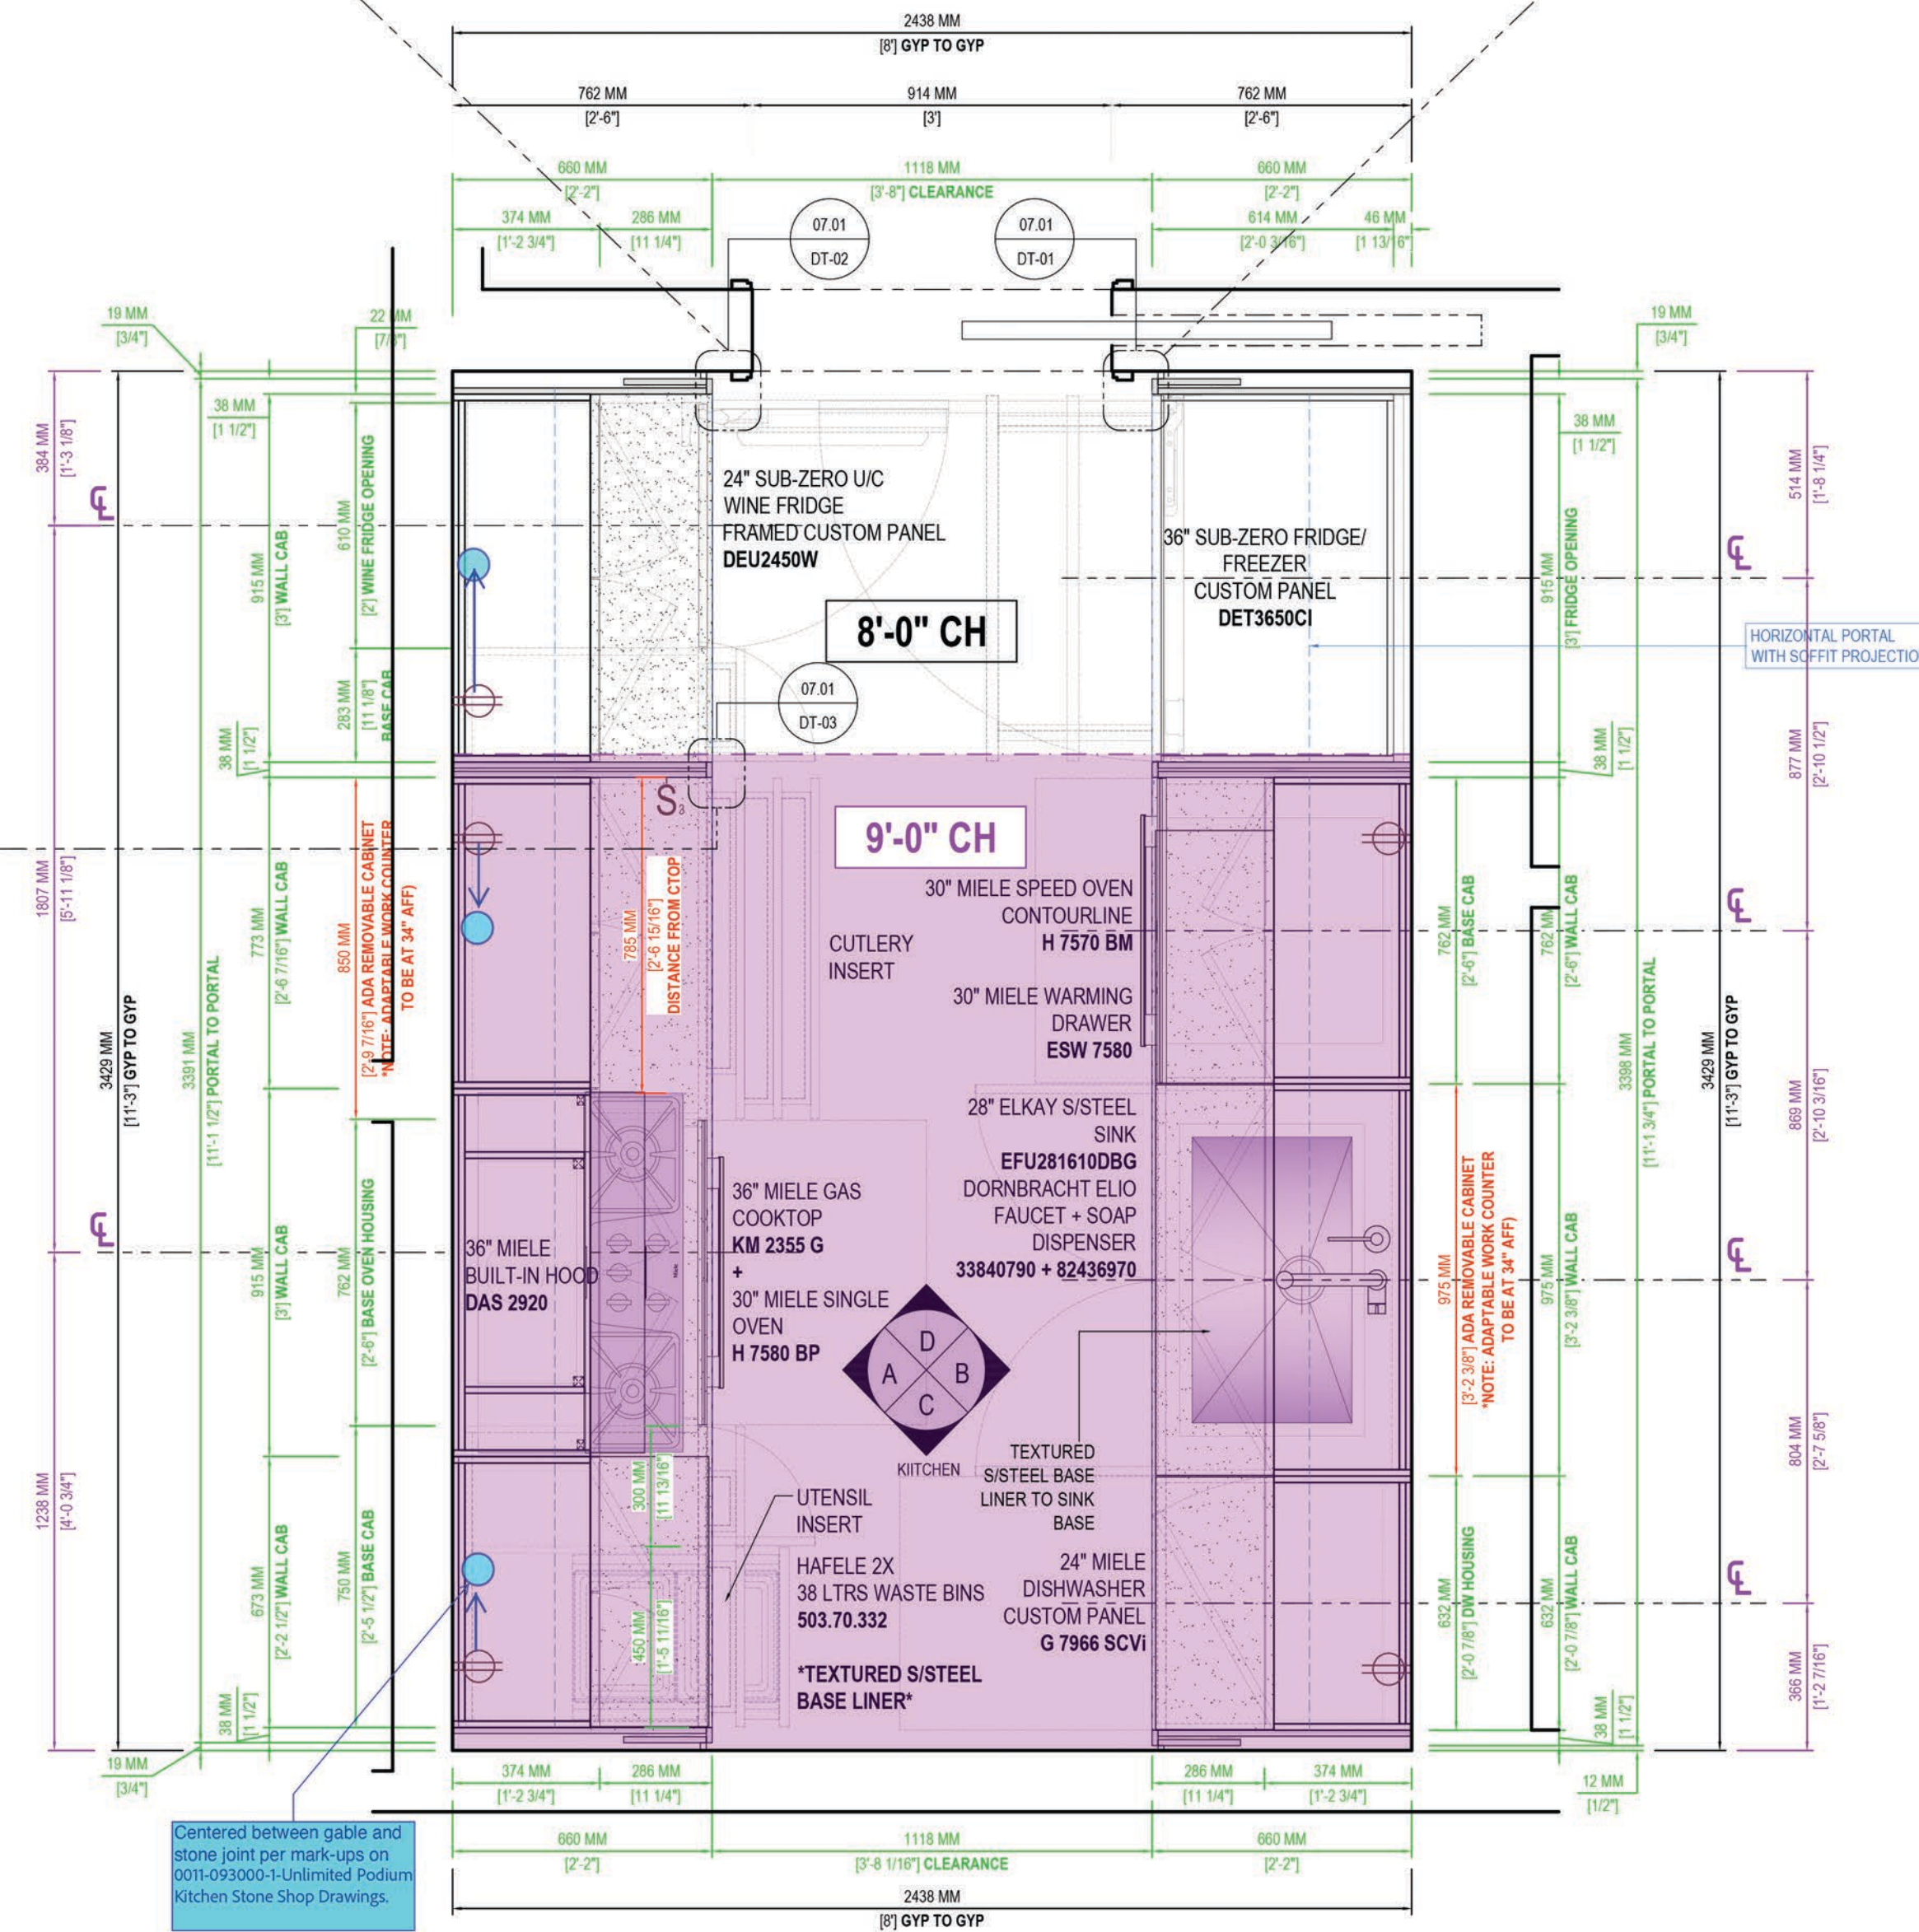

**(1) ONE OF THESE LAYOUTS
NO CABINET HANDLES
NO APPLIANCES
NO PLUMBING FIXTURES**

APARTMENT	FLOOR	QTY	FINISH SCHEME
G	06-14	09	LIGHT SCHEME


NOTE: DARK SCHEME AVAILABLE BY PURCHASER REQUEST ONLY

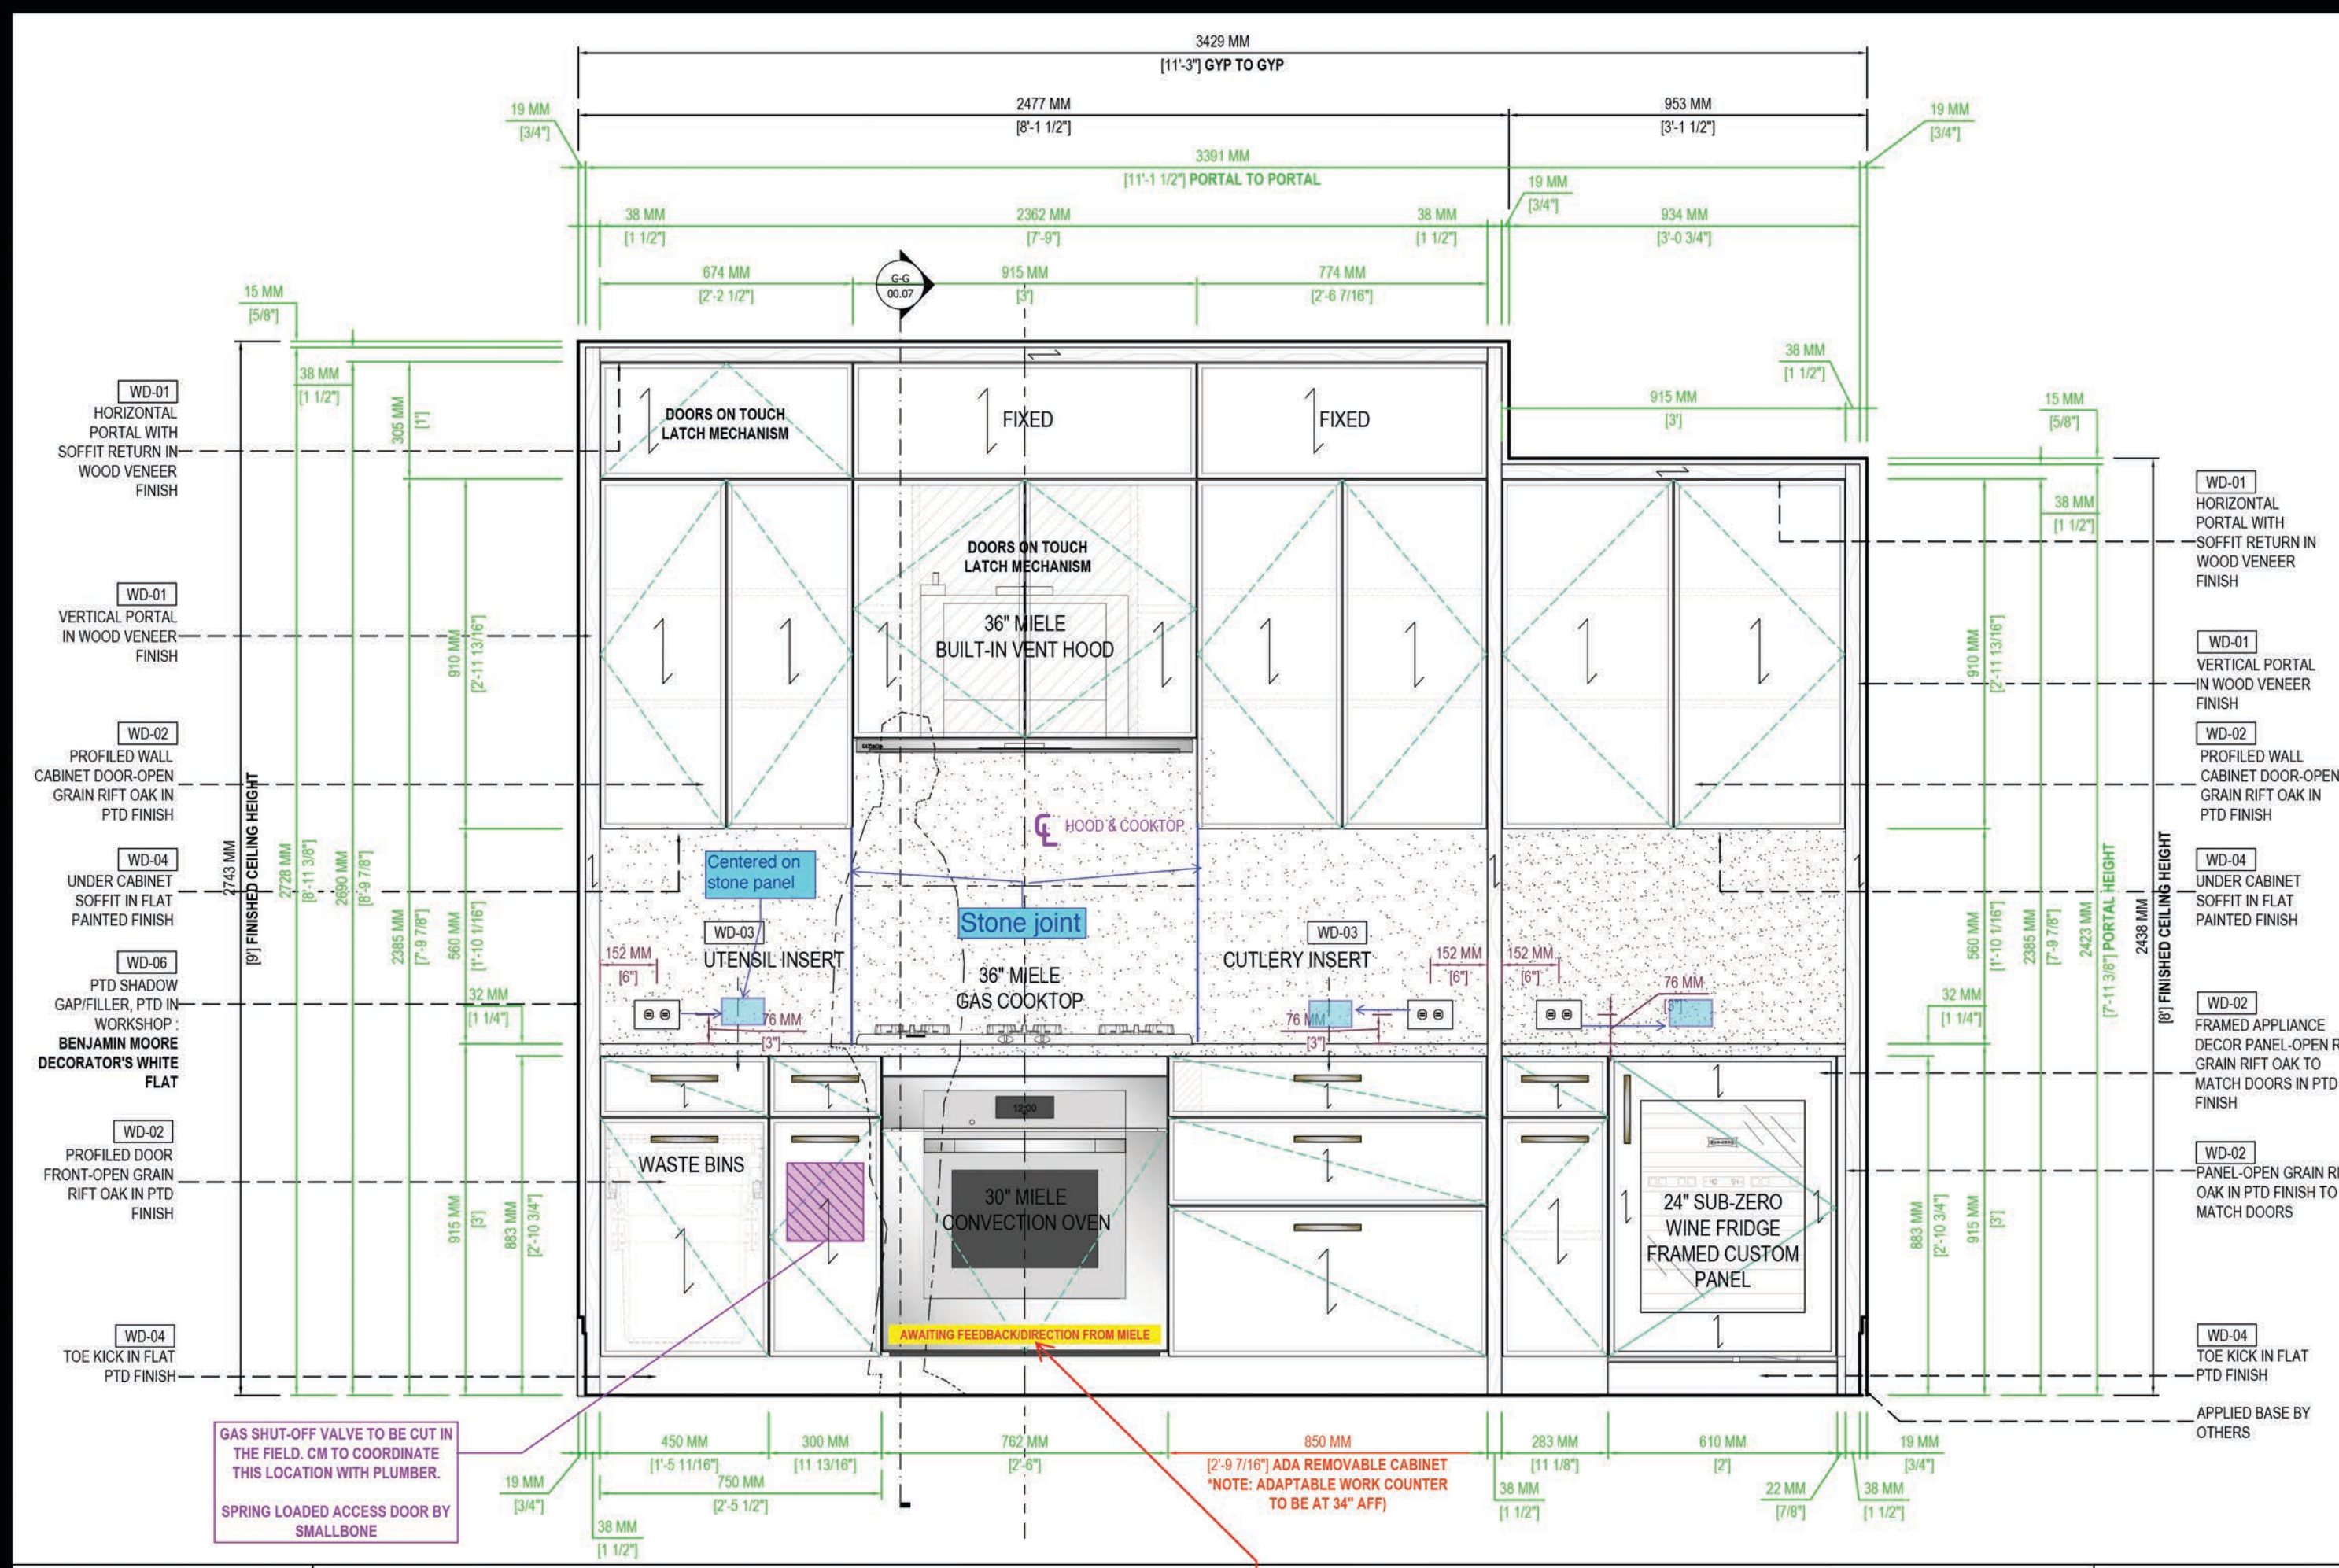

02

KITCHEN ELEVATION A
TYPE 5


SCALE
3/4"=1'-0"

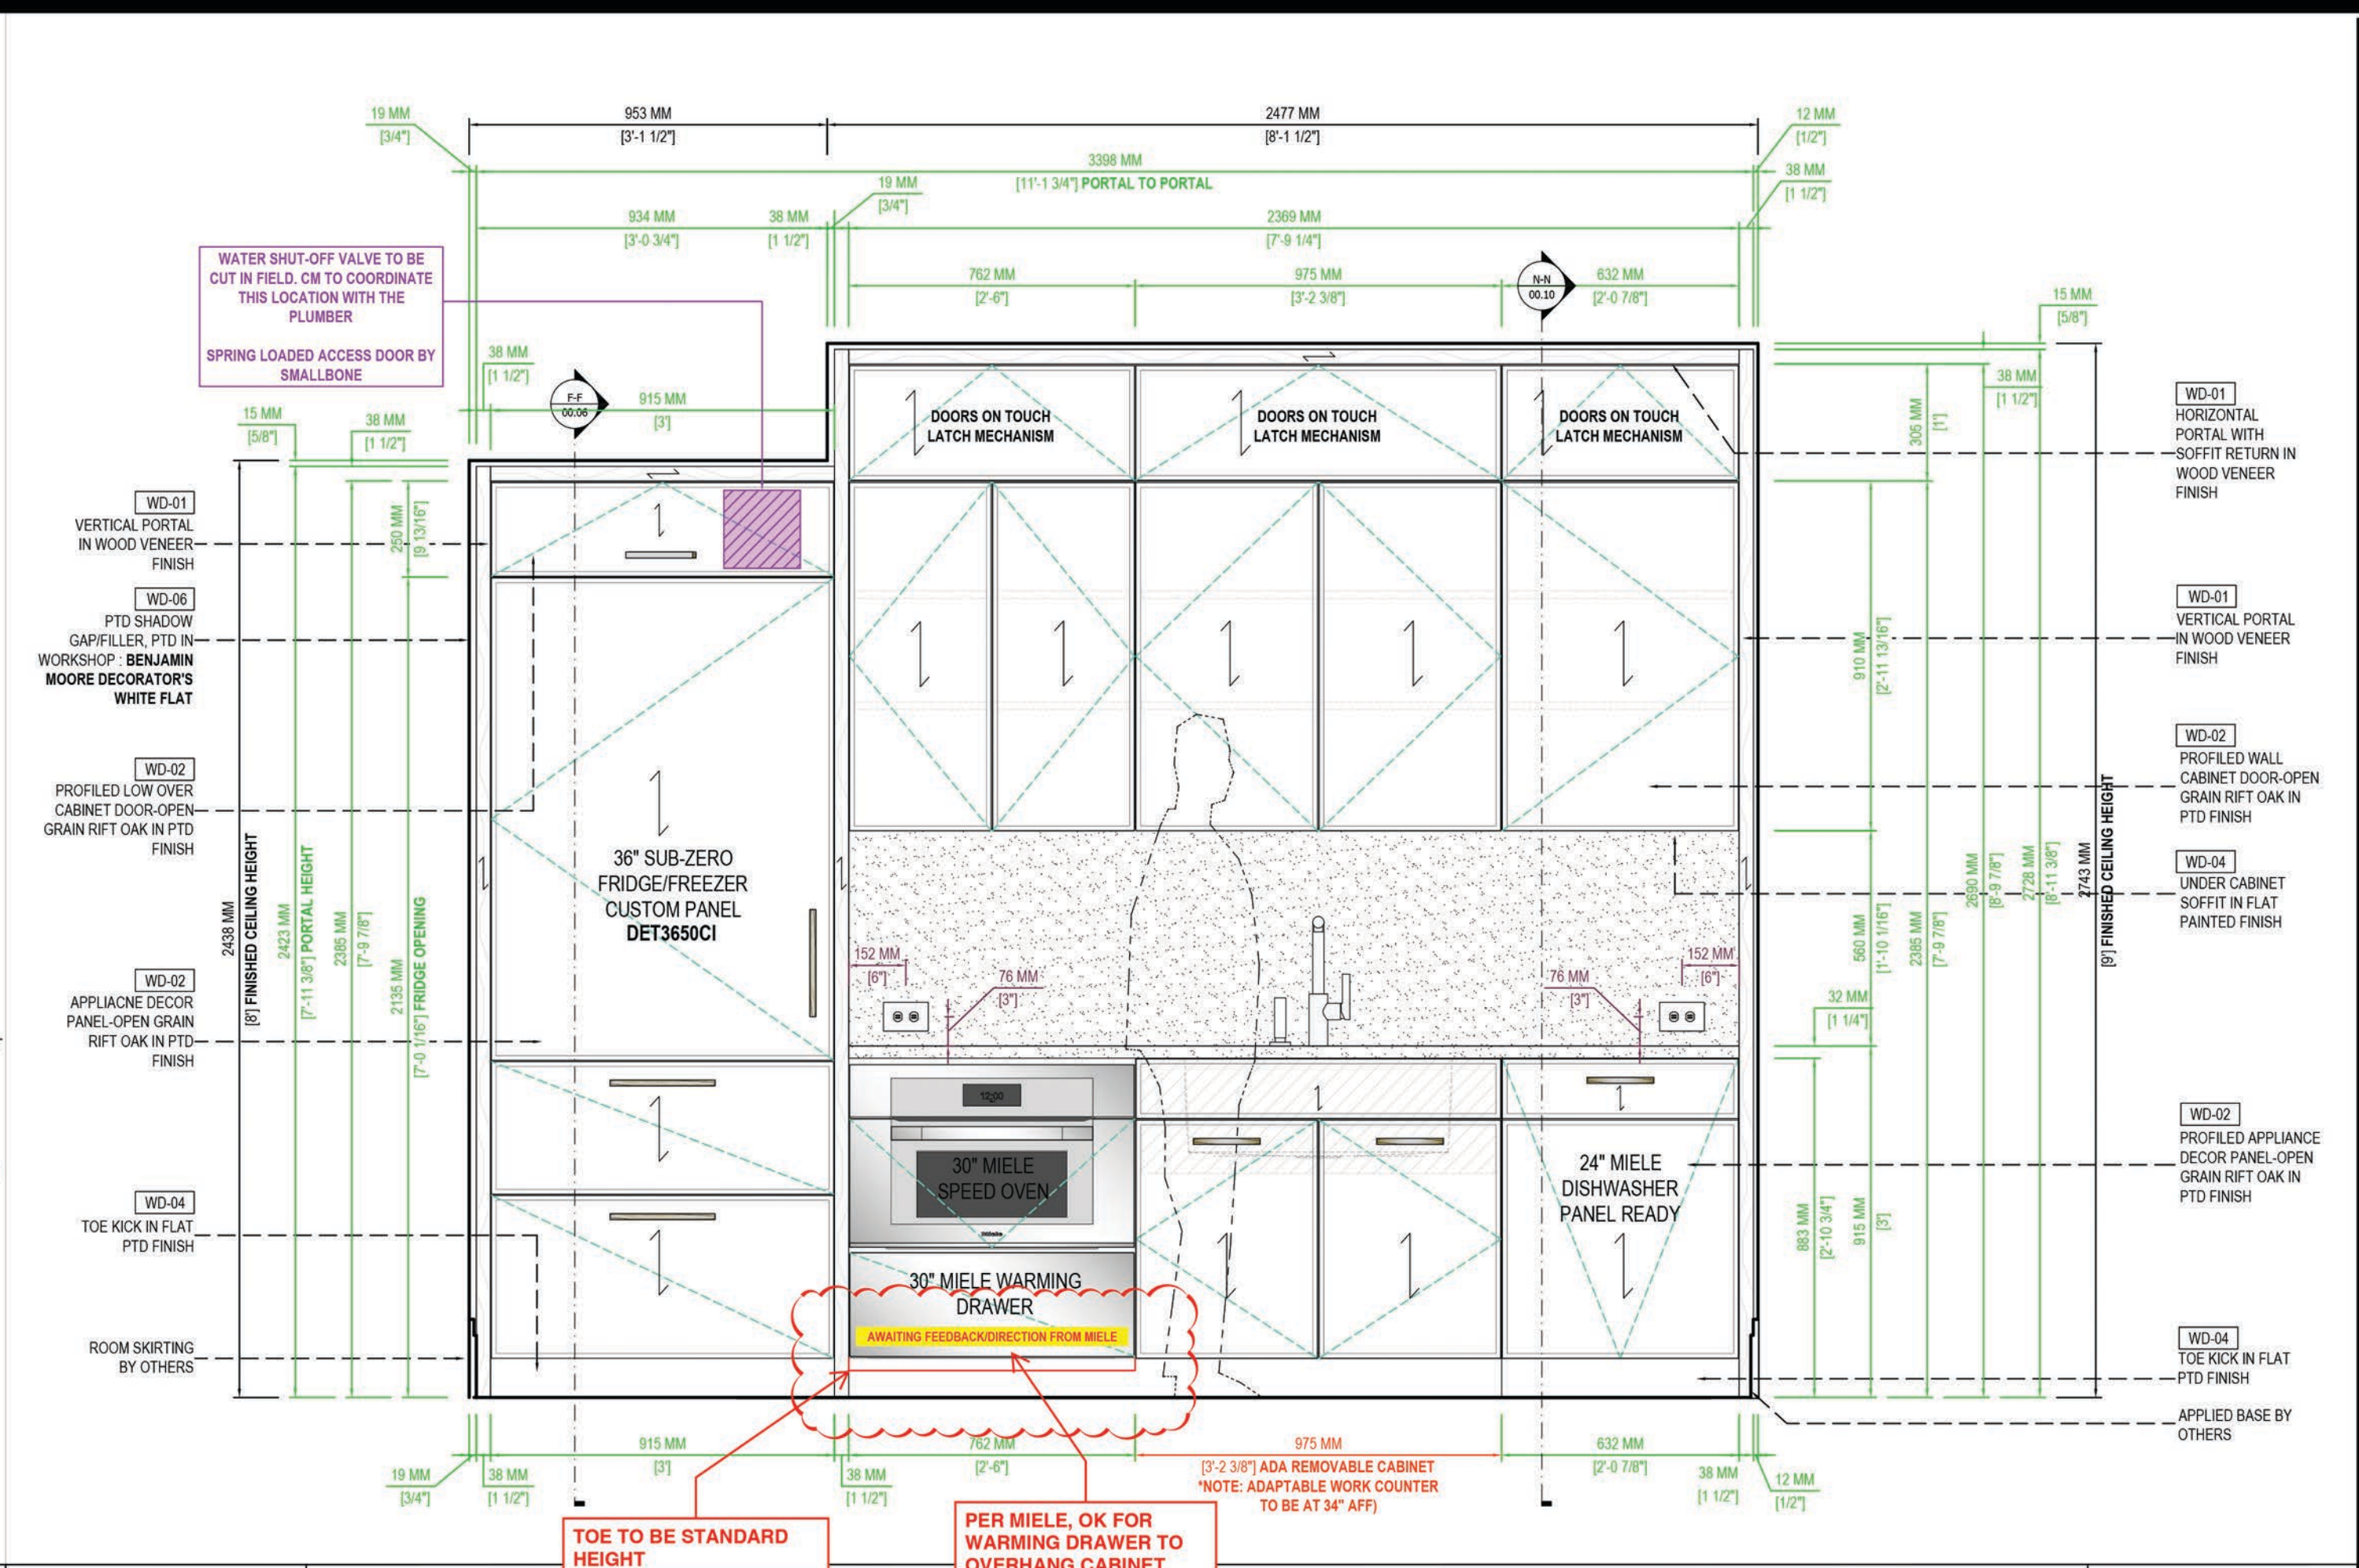

03

KITCHEN ELEVATION B
TYPE 5


SCALE
3/4"=1'-0"

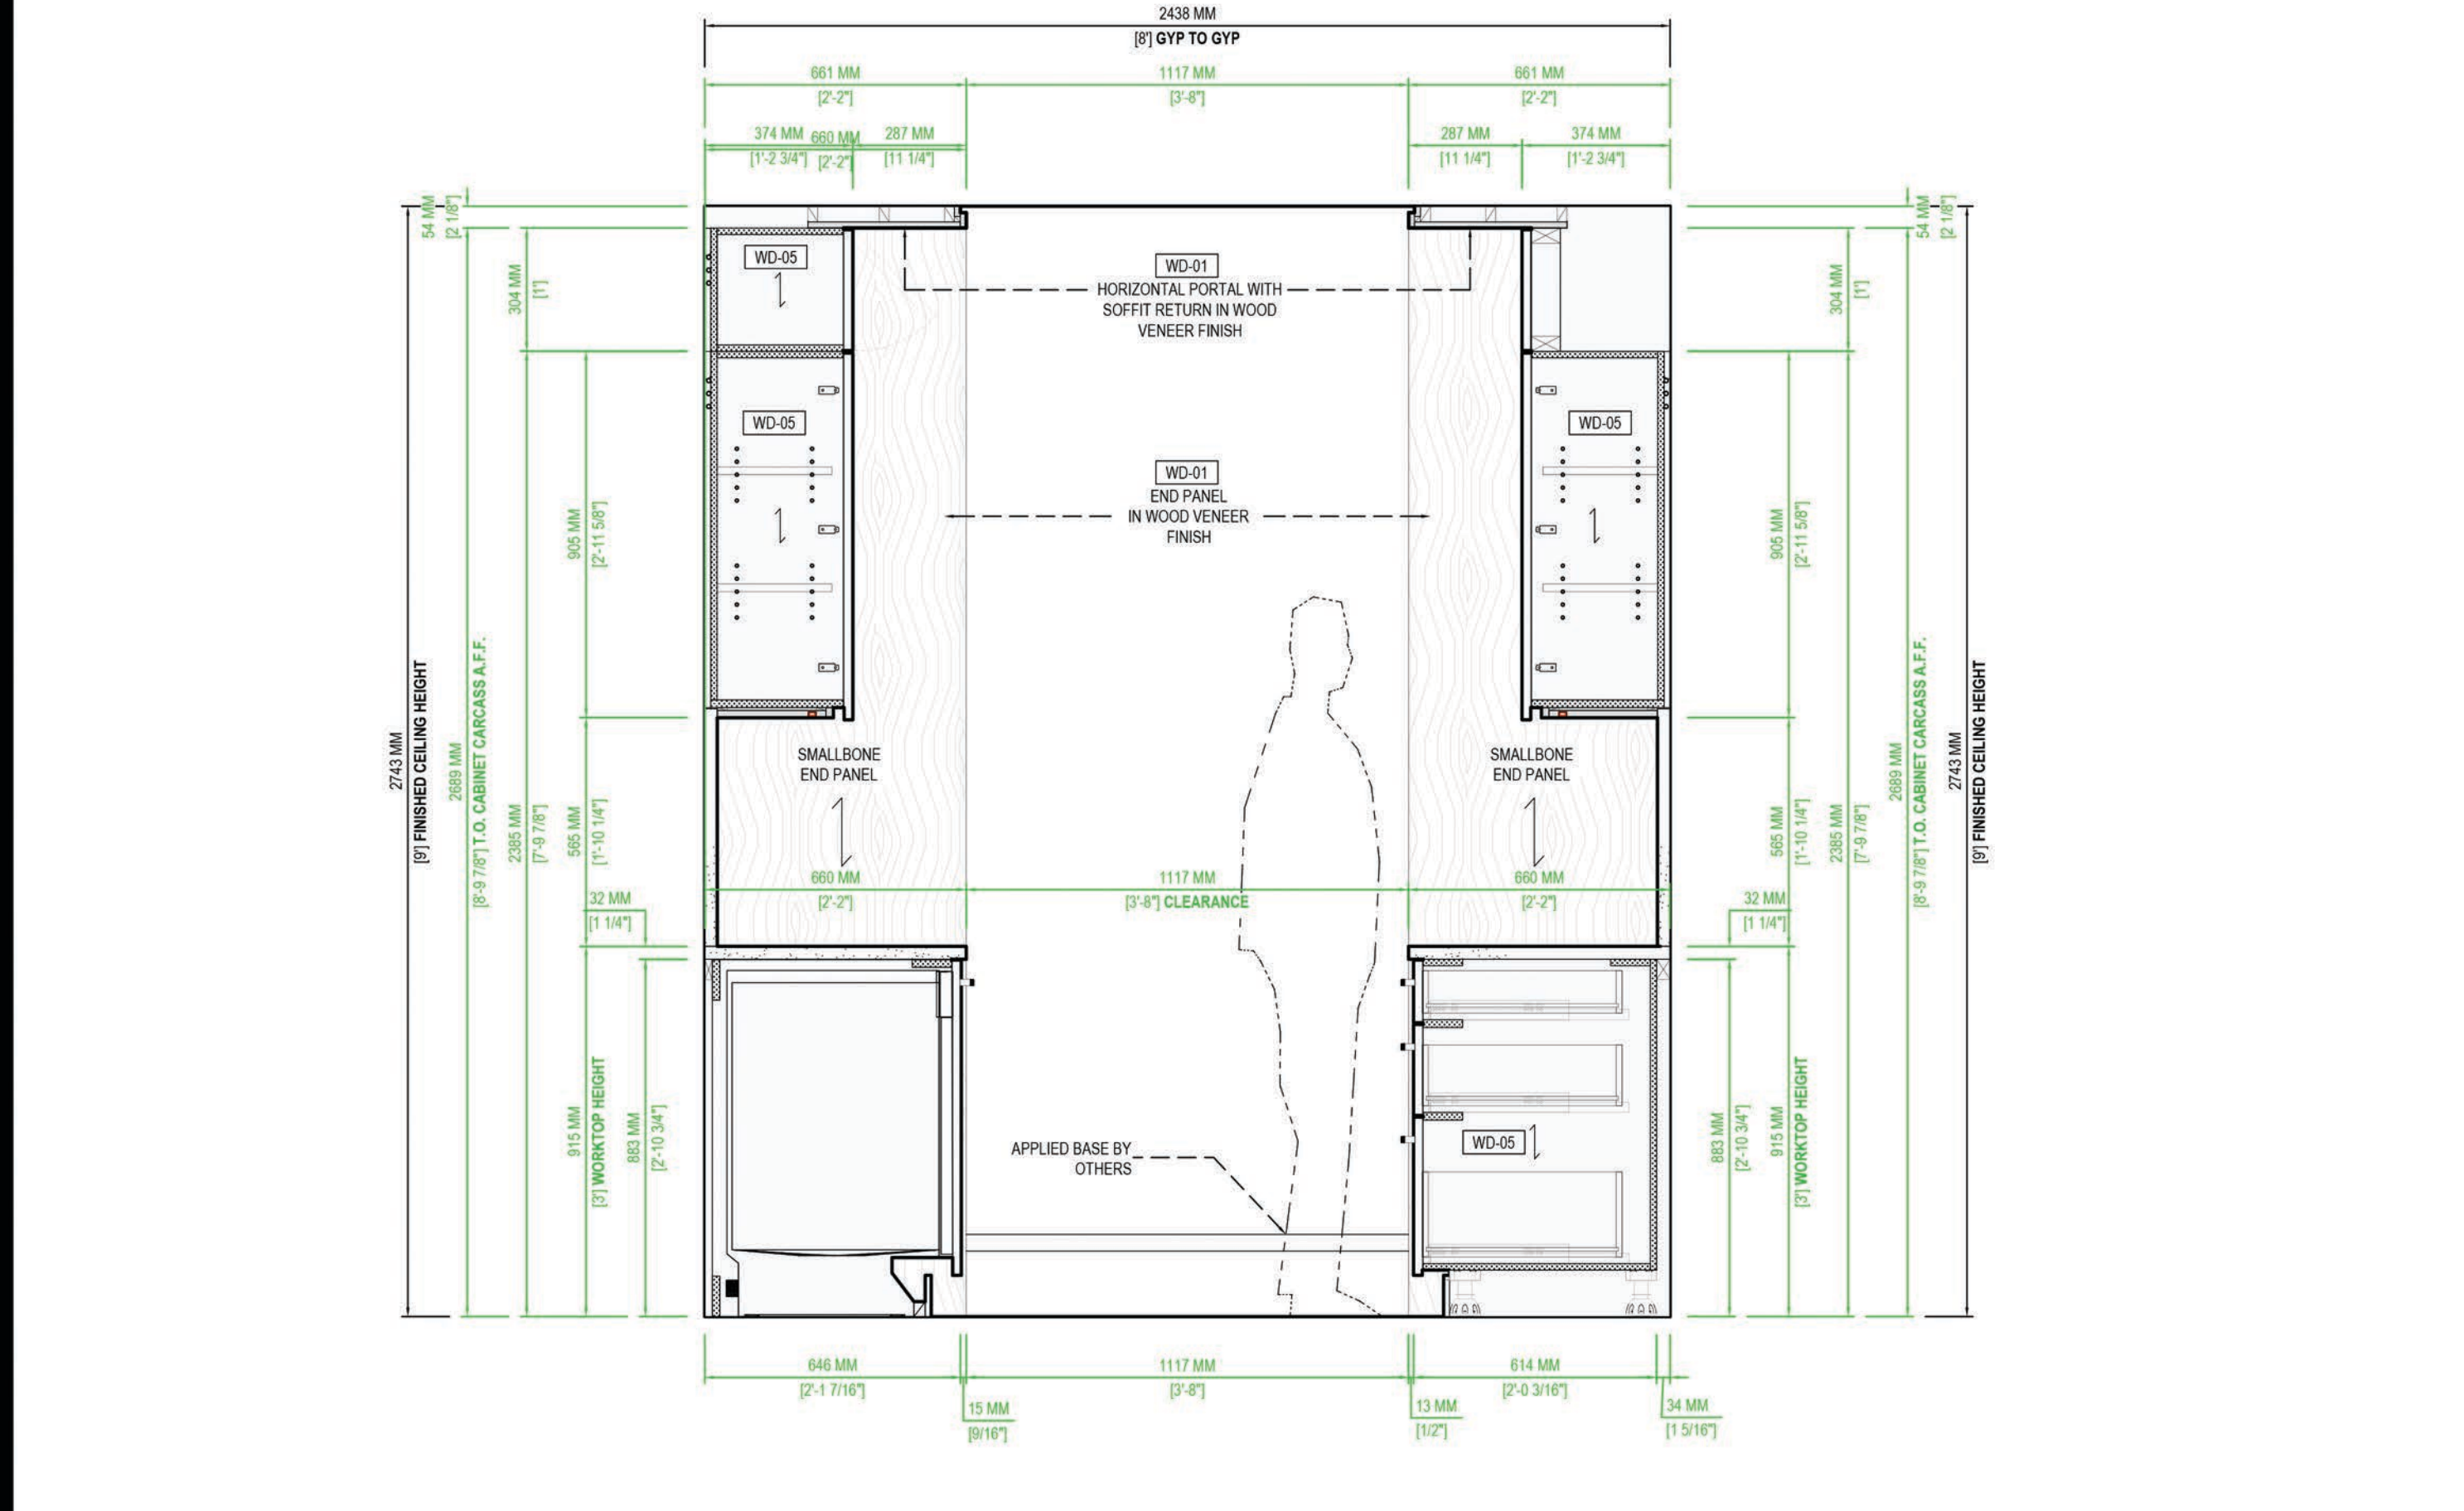

04

KITCHEN ELEVATION C
TYPE 5

SCALE
3/4"=1'-0"

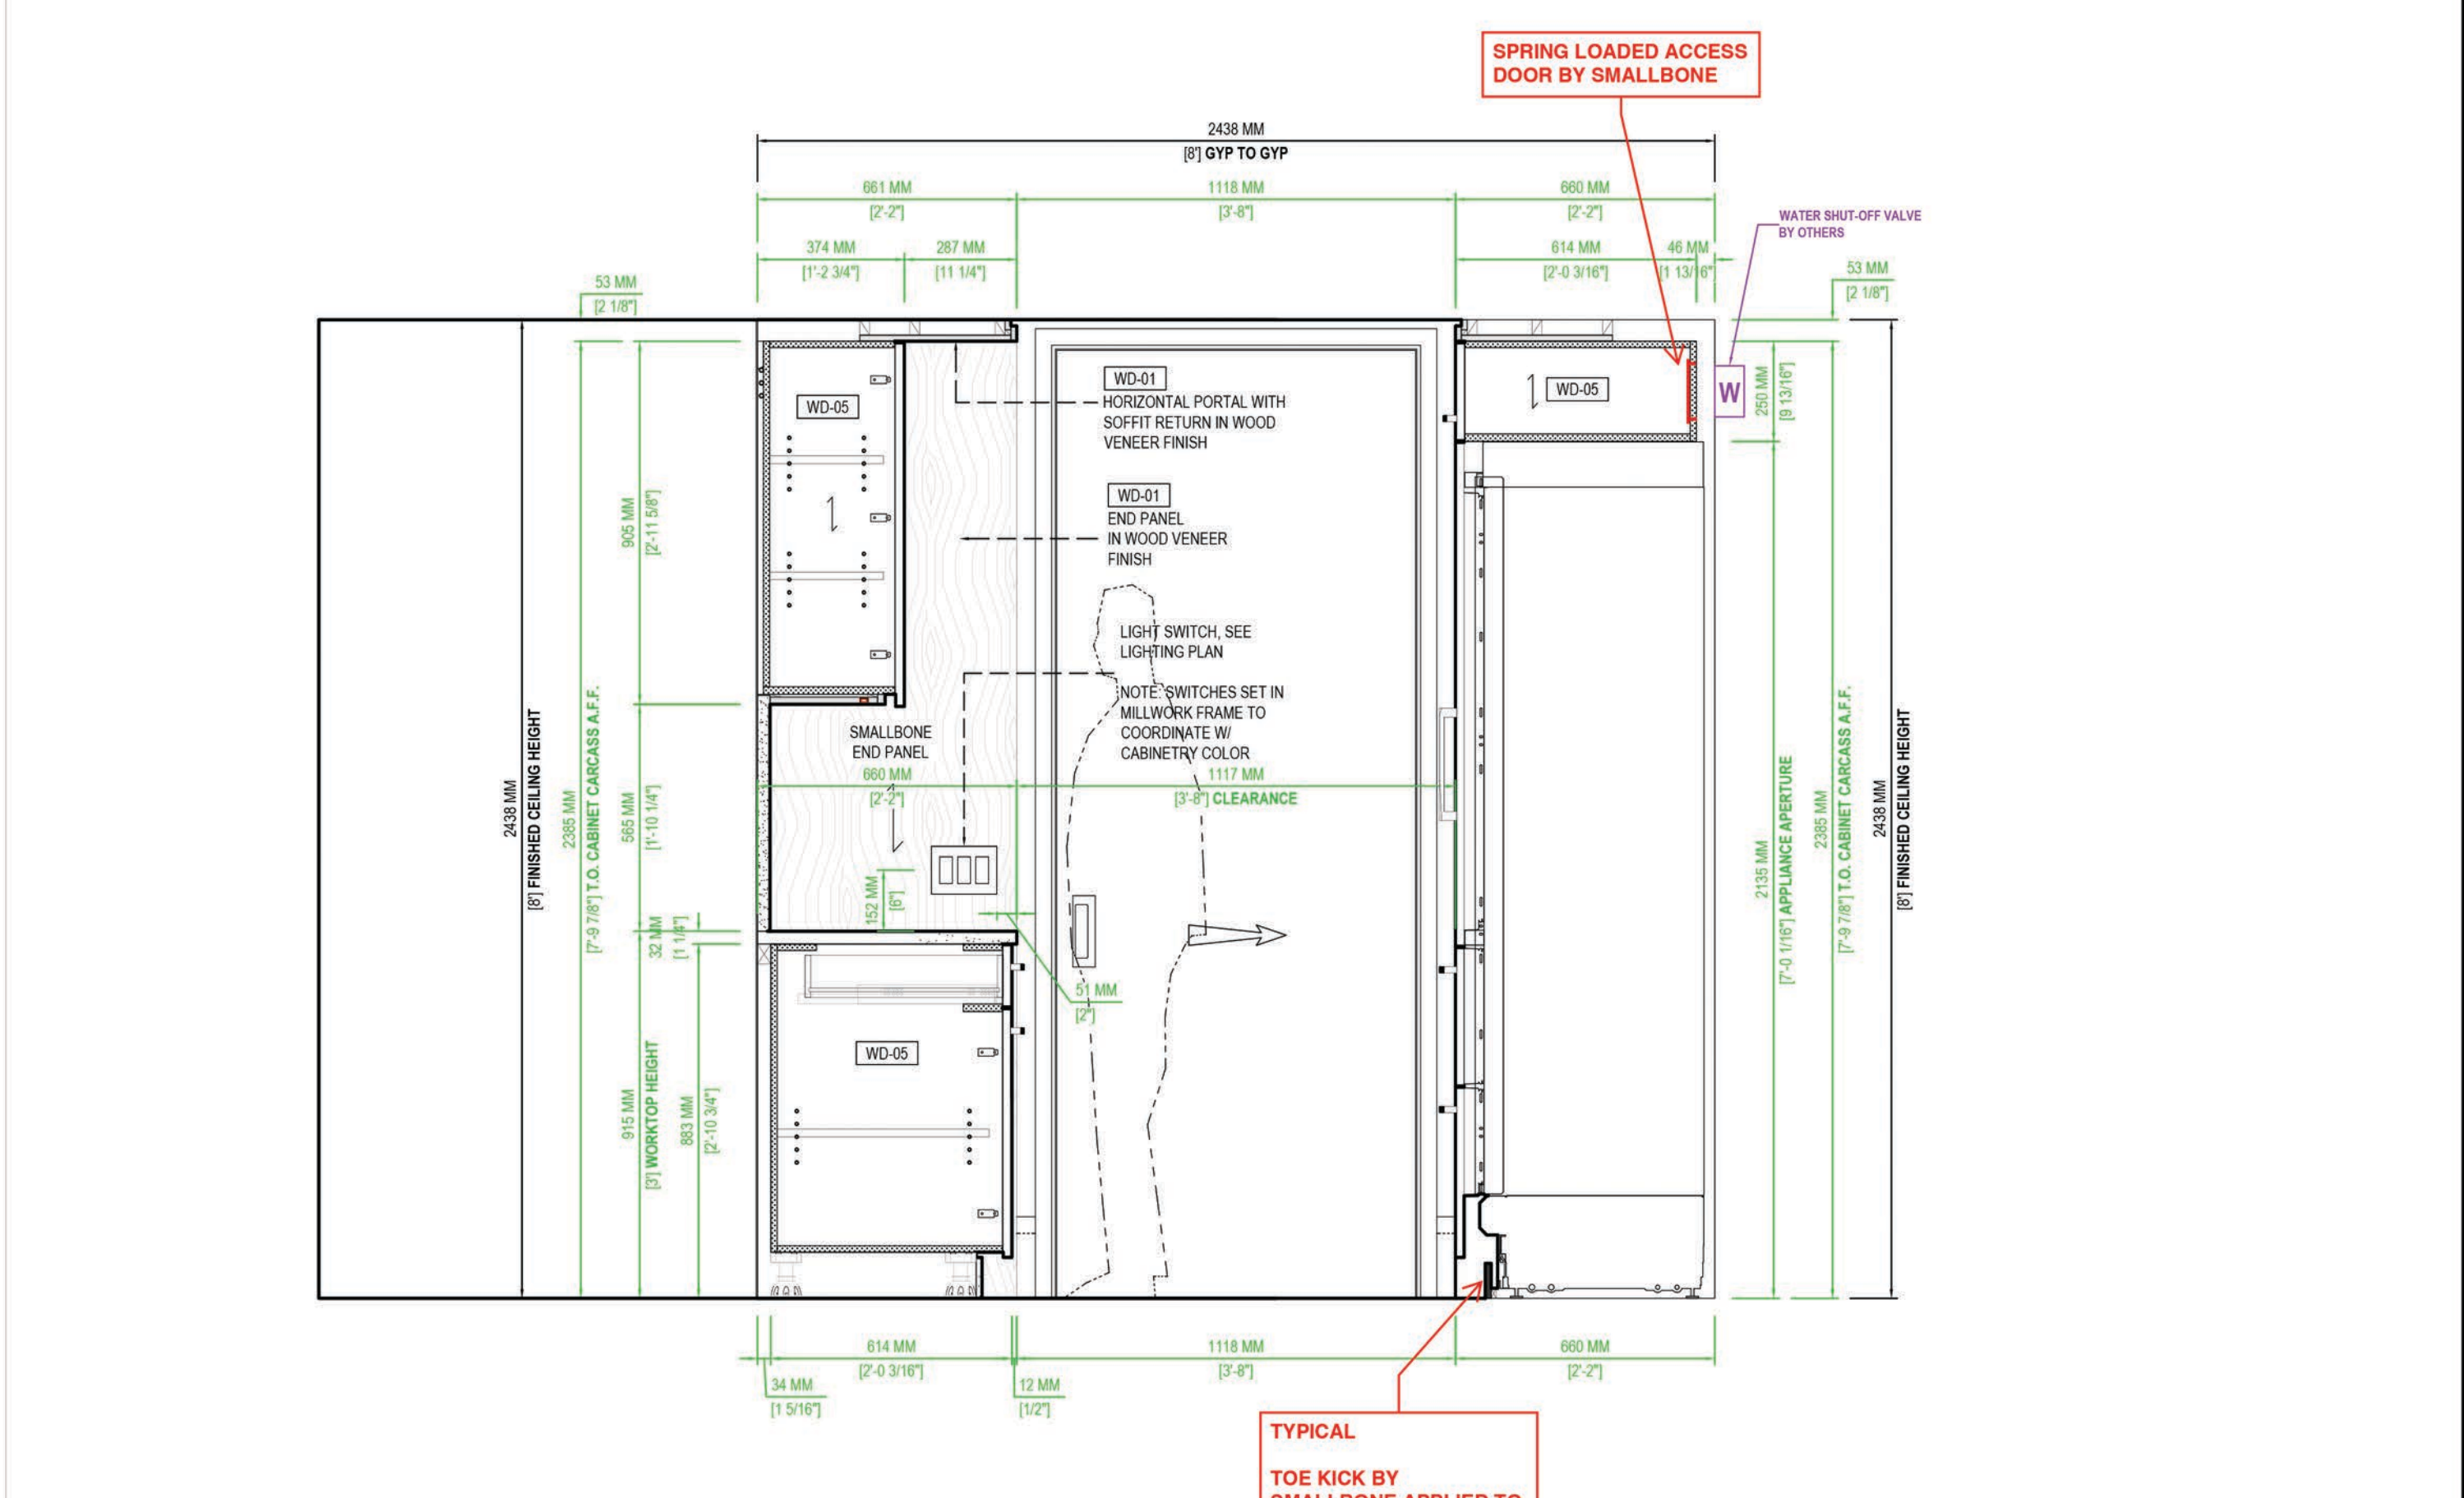

05

KITCHEN ELEVATION D
TYPE 5

SCALE
3/4"=1'-0"